


RANCHO #2
UNIT - 110

AREA TABULATION


SUITE 110 = - S.F.

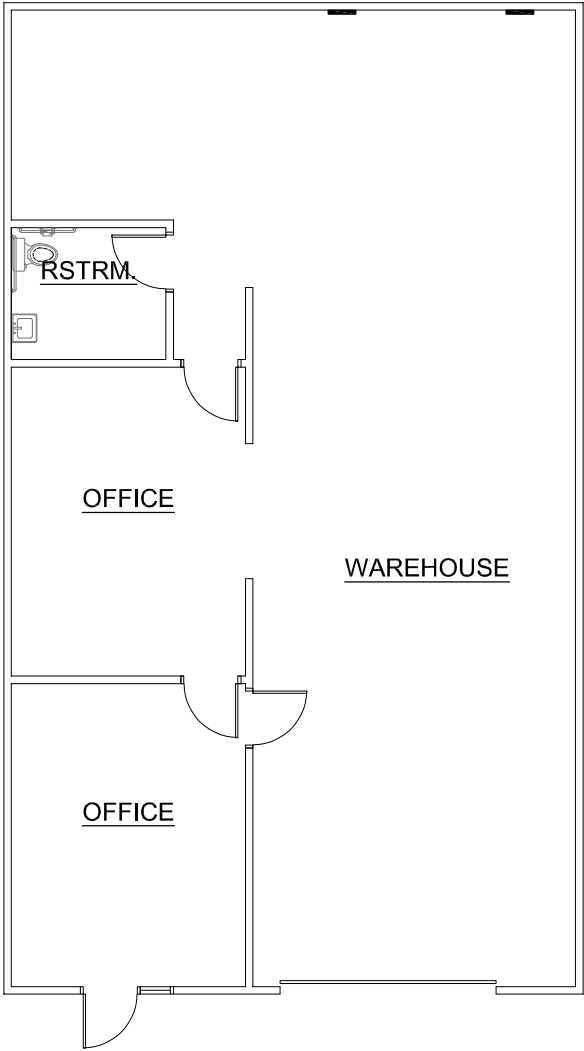

NOTES:

(E) ELECTRICAL PANEL
(C) DATA PANEL

FIRE SPRINKLED - YES
FIRE ALARMED - YES

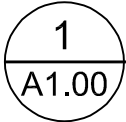

#110 AS-BUILT PLAN

SCALE: 3/32" = 1'-0"

REVISIONS	#	DATE	DESCRIPTION	DRAFTER INFORMATION	DRAFTING COMPANY:	PROJECT INFORMATION	PROJECT NAME:	DRAWING INFORMATION	PLOT DATE:
					STREAMLINE CONCEPT DRAFTING & DESIGN, LLC		RANCHO PROFESSIONAL PLAZA		09-04-2020
					COMPANY ADDRESS: 6935 ALIANTE PARKWAY, STE. 104-432 NORTH LAS VEGAS, NEVADA 89084		PROJECT ADDRESS: 3013 & 3065 NORTH RANCHO DRIVE LAS VEGAS, NEVADA 89130		PHASE AS-BUILT SUBMITTAL
					COMPANY CONTACT: DYLAN YORKE - OWNER 702-416-0795		PROJECT NUMBER: 016-18002		SHEET NAME AS-BUILT FLOOR PLAN
									SHEET NO.
									A1.00