



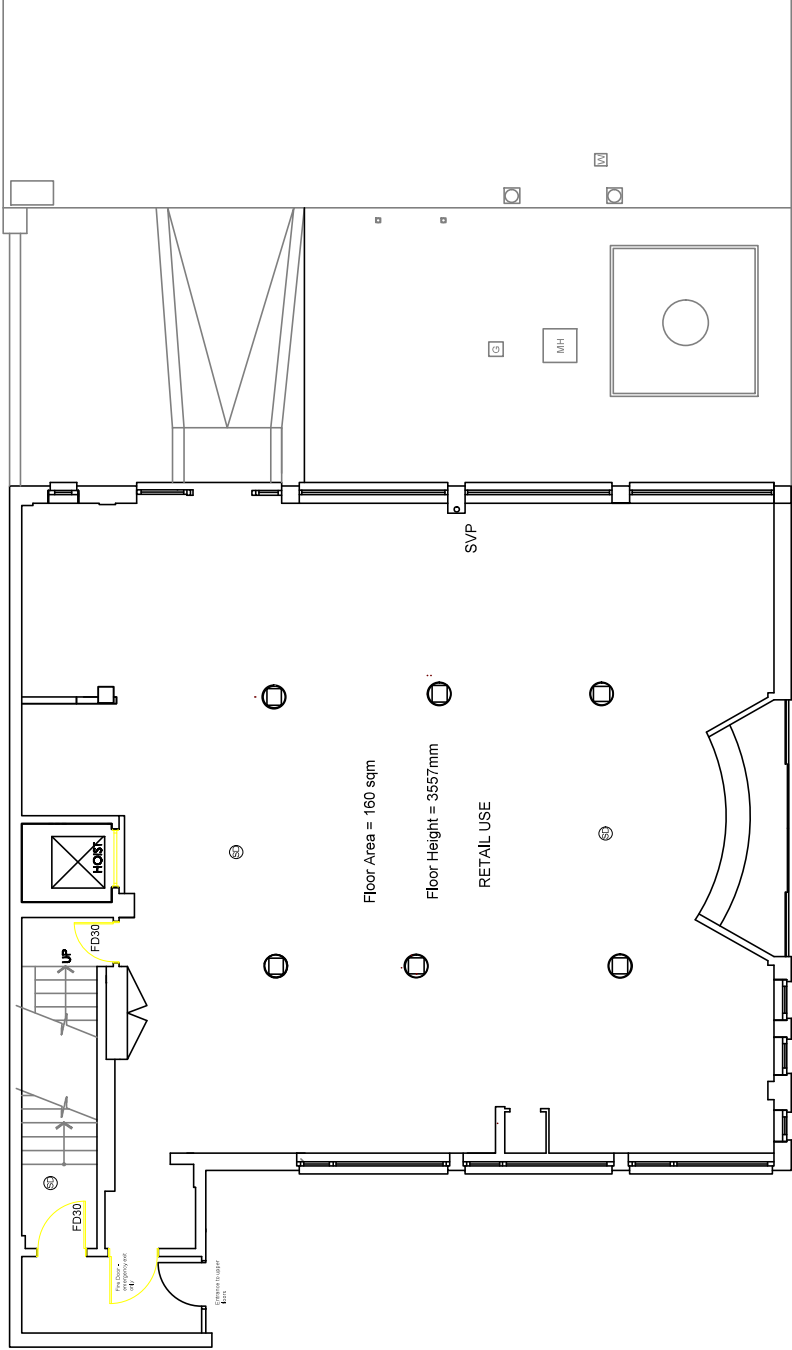

Proposed Ground Floor Plan
Scale: 1:100

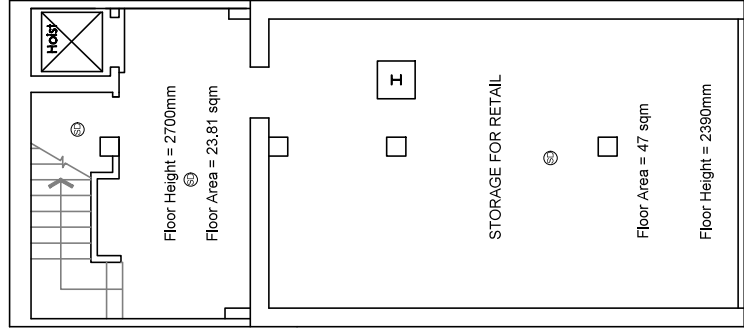

Proposed Basement Floor Plan
Scale: 1:100

SYMBOL	DESCRIPTION
Ⓜ	MAINT OPERATED SMOKE DETECTOR
Ⓜ	EMERGENCY LIGHT
Ⓜ	CONSUMER UNIT
Ⓜ	FIRE EXIT SIGN
Ⓜ	EXTRACT FAN
Ⓜ	HEAT DETECTOR
Ⓜ	EXTERNAL LIGHT
Ⓜ	FIRE PANEL
Ⓜ	assembly point
Ⓜ	Fire exit
Ⓜ	Fire extinguisher

NOTE: CAT 6 CABLE AND SKY PLUS CABLE TO BE USED

Ⓜ Smoke alarm and heat alarms as per BS 5446-2: 2003

Ⓜ Smoke alarm and heat alarms as per BS 5446-2: 2003

Ⓜ Emergency lights as per BS 5266-1: 2005

FD30 All doors to be self-closing fire door unless otherwise stated.

All windows to have 0.3m x 2.0m operable area with 450mm in either direction.

Dimensions to be verified on site
DO NOT SCALE FROM THIS DRAWING.
No responsibility is taken for their accuracy.
This drawing is the property of **BANCIL PROPERTY CONSULTANTS LTD**
Copyright is reserved by them and the drawing is issued on the understanding that it is not to be reproduced, stored, or used in any way without the consent in writing of **BANCIL PROPERTY CONSULTANTS LTD**



BANCIL
PROPERTY
CONSULTANTS
LTD

Site Address:
137 Ladbroke Grove
London
W11 1PR

Client Detail:
137 Ladbroke Grove
London
W11 1PR

Title:
Proposed Ground Floor Plan
Proposed Basement Floor Plan

Revisions:
Rev Revision
Date

Drawn By: NM
Checked By: SM
Date: 02/2026
Drawing No. PL1/SM/3513-04

Scale: 1:100
Paper Size: A3